
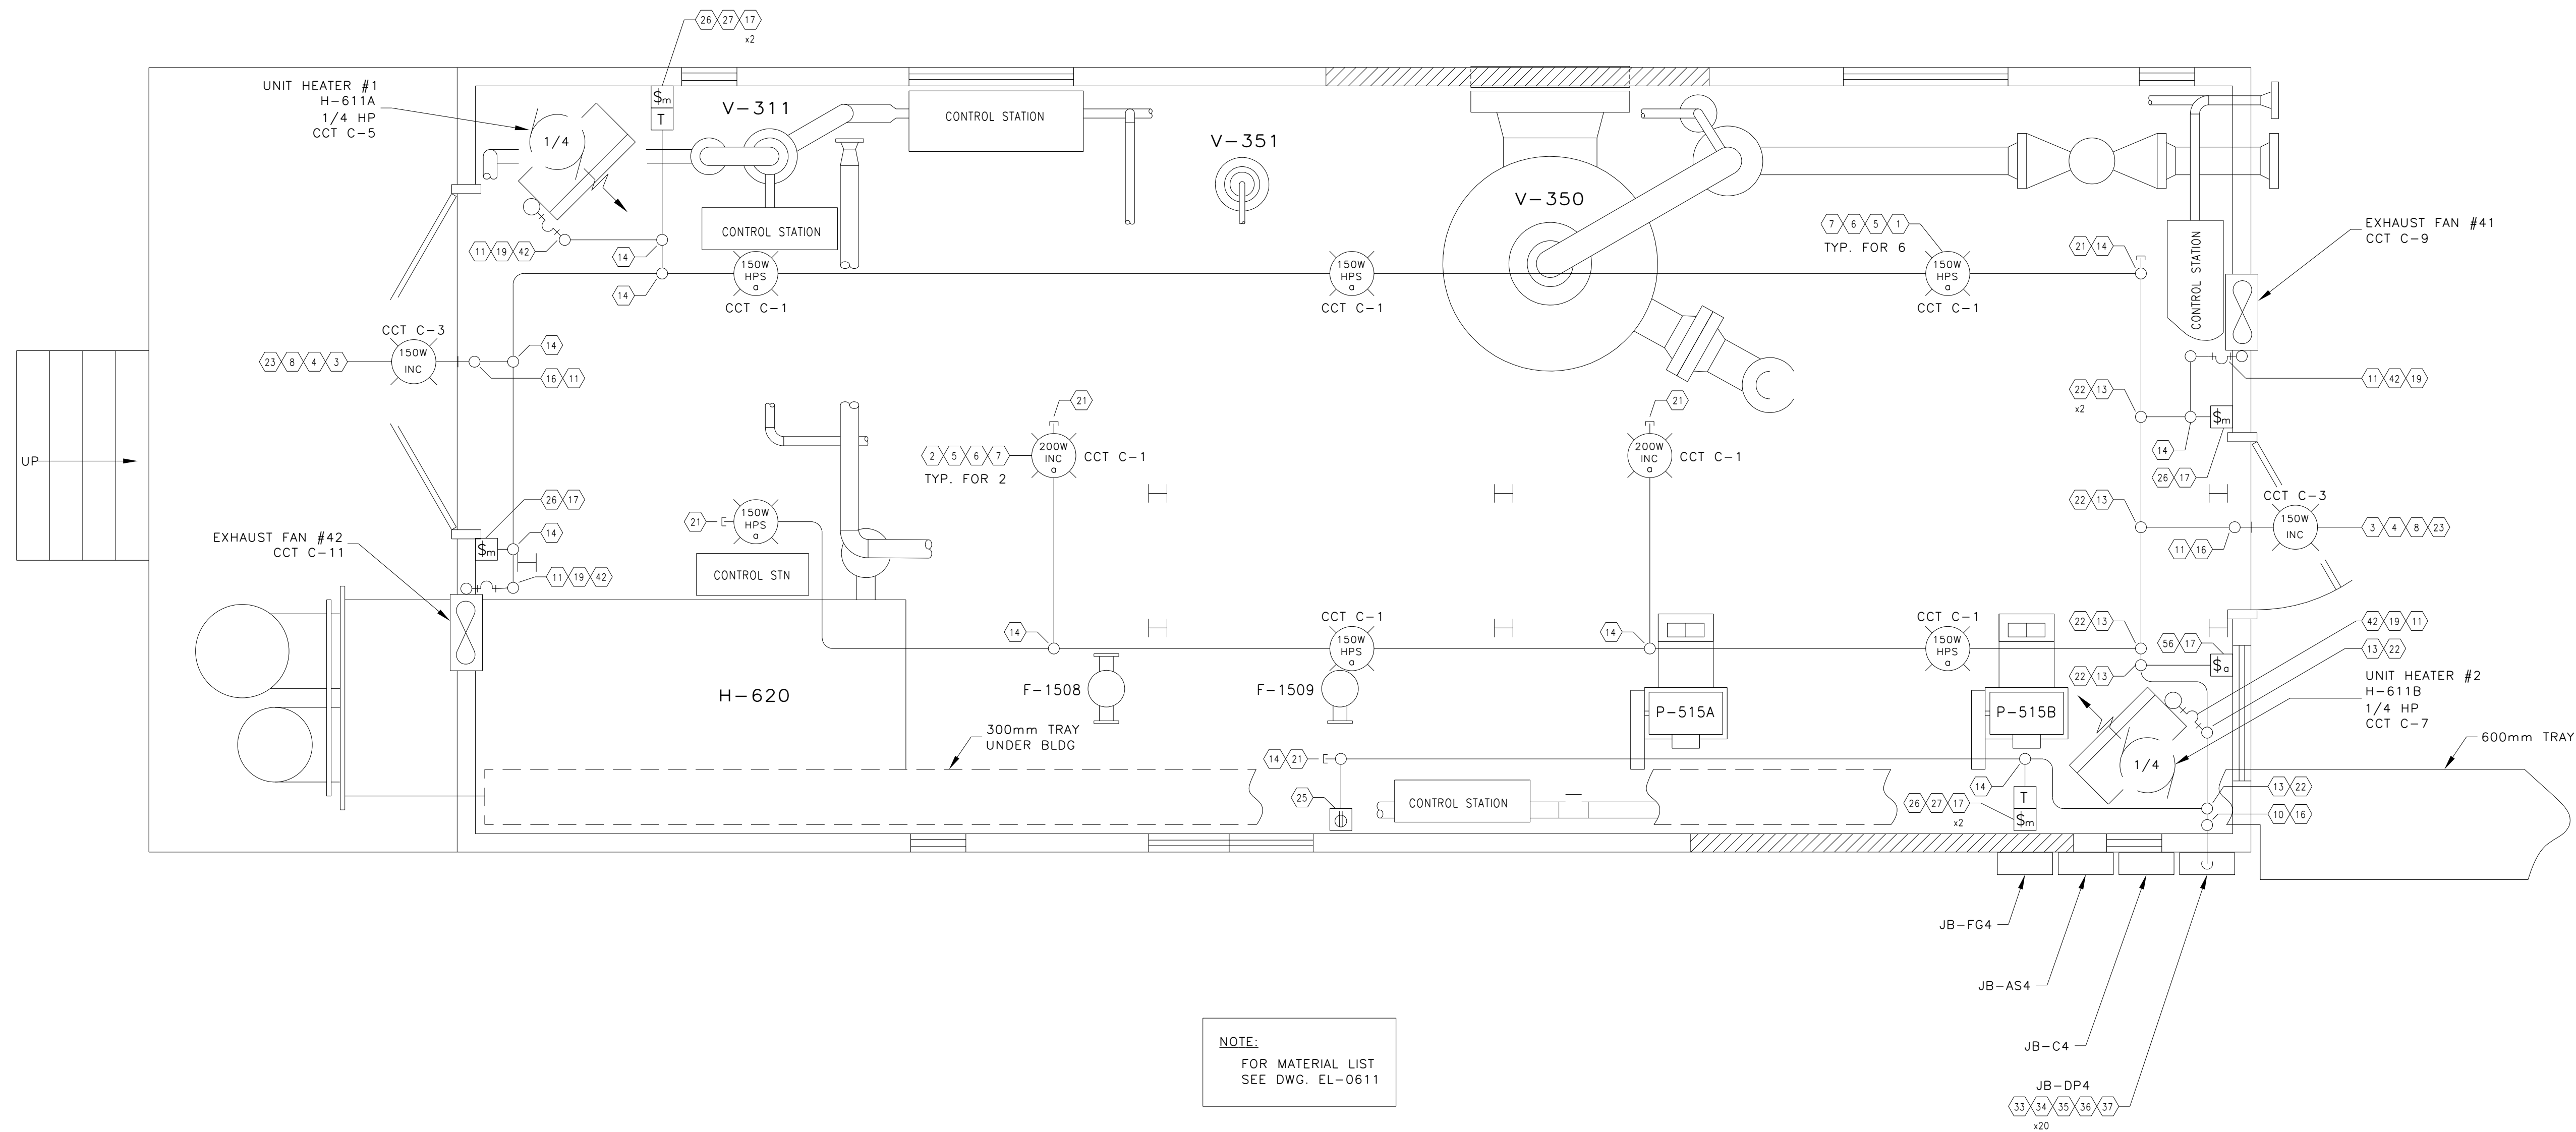


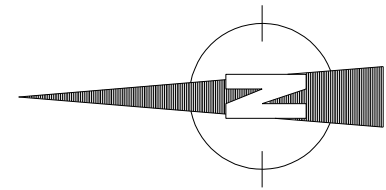

REF DWG NO	REFERENCE DRAWING DESCRIPTION	NO	REVISION HISTORY	REV AUTHOR	REV DATE	ISSUED FOR	NO	CURRENT REVISION	ISSUED FOR
		A	ISSUED FOR BID	DMC	1996/01/19	BID	03	UPDATED PER FIELD SUPPLIED MARK UPS	AS BUILT
		1	ISSUED FOR CONSTRUCTION	JG	1996/01/31	CONSTRUCTION			DOC DATE 2006/02/06
		2	AS BUILT	JG	1996/06/07	AS BUILT			DOC AUTHOR EPC_TCG
		3							SCALE 1:20
		4							ALTERNATE IDENTIFIER 95045-E0604L
		5							SURFACE LSD 02-33-083-25W4
		6							DOCUMENT IDENTIFIER EL-0604-01

MUSKWA RIVER GAS PLANT 02-33-083-25W4

GLYCOL DEHYDRATION BUILDING
LIGHTING LAYOUT